
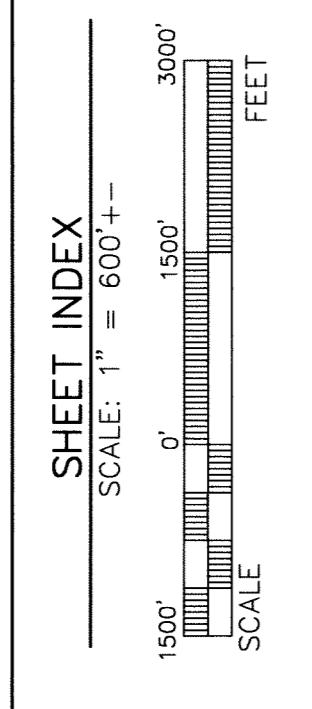


THE PLANS AND SPECIFICATIONS HEREBY SUBMITTED SHALL BE CONSIDERED AS A COMPLETE SET OF DOCUMENTS AND SHALL BE OPENED TO THE PUBLIC FOR REVIEW AND COMMENT. THE ENGINEER SHALL BE RESPONSIBLE FOR THE ACCURACY AND COMPLETENESS OF THE INFORMATION PROVIDED TO THE BOARD OF SUPERVISORS. THE BOARD OF SUPERVISORS SHALL BE RESPONSIBLE FOR THE ACCURACY AND COMPLETENESS OF THE INFORMATION PROVIDED TO THE PUBLIC.

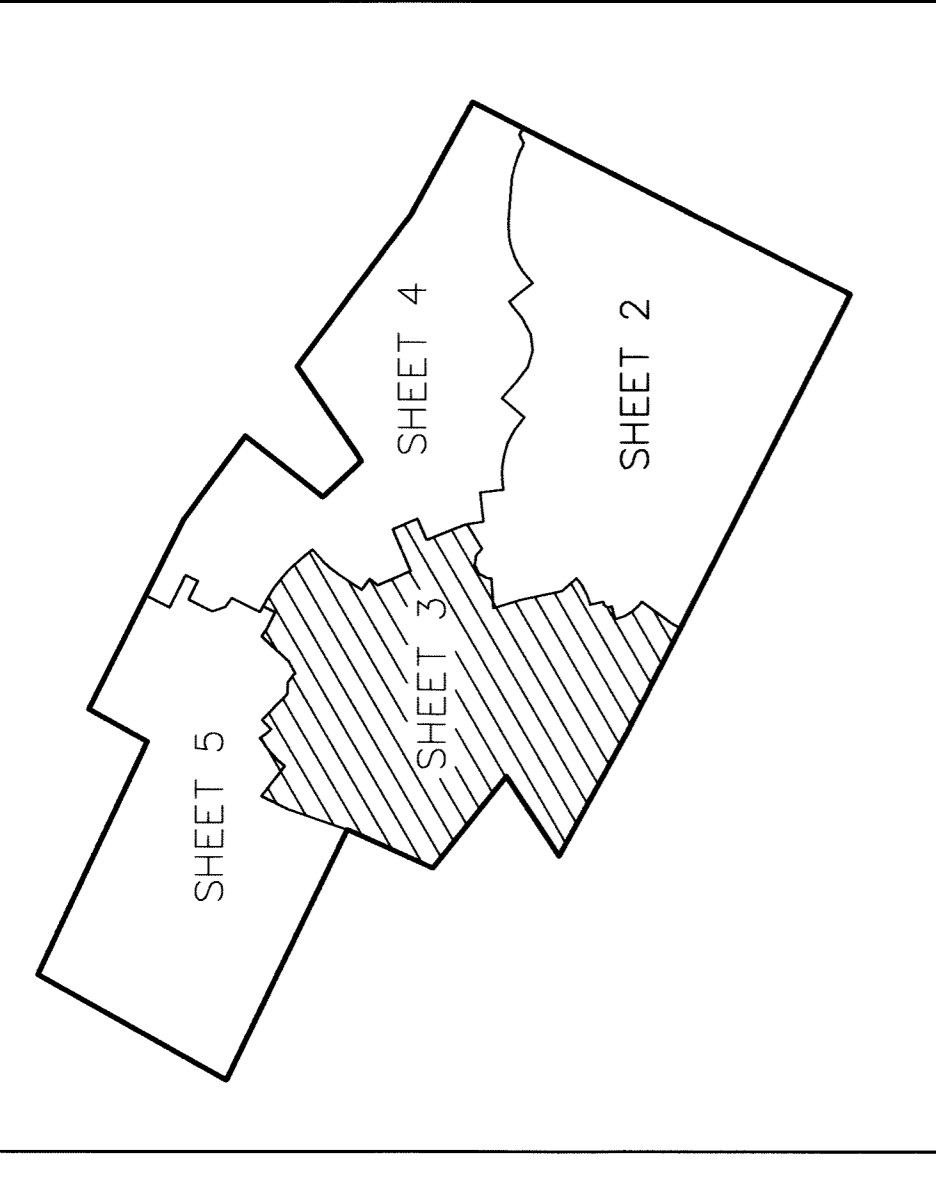

**PLAN INDEX**

INDEX PLAN	SHEET NO.
1	1
2 - 5	2 - 5
6 - 7	6 - 7
8 - 11	8 - 11
12 - 15	12 - 15
16 - 19	16 - 19
20 - 35	20 - 35
36	36
37 - 38	37 - 38
39	39
40 - 41	40 - 41
42	42
43	43
44	44
1 - 4 OF 4	1 - 4 OF 4


**GENERAL NOTES:**

1) ALL GENERAL NOTES AND SITE DEVELOPMENT DATA WILL BE FOUND ON SHEET 1.

2) THE ENGINEERING SHEETS FOR THIS RECORD PLAN WILL BE FOUND ON THE FOLLOWING SHEETS:

- GRADING AND DRAINAGE PLAN 9
- SEDIMENTATION AND EROSION CONTROL PLAN 13
- UTILITY, LANDSCAPE AND LIGHTING PLAN 17

NO.	DESCRIPTION	DATE	BY
1	REVISION		
2	REVISION		
3	REVISION		
4	ADD ADDITIONAL UTILITY EASEMENTS	1-6-05	CM
5	REVISION PER 7-6-03 SUPERVISORS' APPROVAL	7-7-03	SOC
6	REVISION PER 7-6-03 SUPERVISORS' APPROVAL	7-7-03	SOC
7	REVISION PER 7-6-03 SUPERVISORS' APPROVAL	7-7-03	SOC
8	REVISION PER 7-6-03 SUPERVISORS' APPROVAL	7-7-03	SOC
9	REVISION PER 7-6-03 SUPERVISORS' APPROVAL	7-7-03	SOC
10	REVISION PER 7-6-03 SUPERVISORS' APPROVAL	7-7-03	SOC
11	REVISION PER 7-6-03 SUPERVISORS' APPROVAL	7-7-03	SOC
12	REVISION PER 7-6-03 SUPERVISORS' APPROVAL	7-7-03	SOC
13	REVISION PER 7-6-03 SUPERVISORS' APPROVAL	7-7-03	SOC
14	REVISION PER 7-6-03 SUPERVISORS' APPROVAL	7-7-03	SOC
15	REVISION PER 7-6-03 SUPERVISORS' APPROVAL	7-7-03	SOC
16	REVISION PER 7-6-03 SUPERVISORS' APPROVAL	7-7-03	SOC
17	REVISION PER 7-6-03 SUPERVISORS' APPROVAL	7-7-03	SOC
18	REVISION PER 7-6-03 SUPERVISORS' APPROVAL	7-7-03	SOC
19	REVISION PER 7-6-03 SUPERVISORS' APPROVAL	7-7-03	SOC
20	REVISION PER 7-6-03 SUPERVISORS' APPROVAL	7-7-03	SOC
21	REVISION PER 7-6-03 SUPERVISORS' APPROVAL	7-7-03	SOC
22	REVISION PER 7-6-03 SUPERVISORS' APPROVAL	7-7-03	SOC
23	REVISION PER 7-6-03 SUPERVISORS' APPROVAL	7-7-03	SOC
24	REVISION PER 7-6-03 SUPERVISORS' APPROVAL	7-7-03	SOC
25	REVISION PER 7-6-03 SUPERVISORS' APPROVAL	7-7-03	SOC
26	REVISION PER 7-6-03 SUPERVISORS' APPROVAL	7-7-03	SOC
27	REVISION PER 7-6-03 SUPERVISORS' APPROVAL	7-7-03	SOC
28	REVISION PER 7-6-03 SUPERVISORS' APPROVAL	7-7-03	SOC
29	REVISION PER 7-6-03 SUPERVISORS' APPROVAL	7-7-03	SOC
30	REVISION PER 7-6-03 SUPERVISORS' APPROVAL	7-7-03	SOC
31	REVISION PER 7-6-03 SUPERVISORS' APPROVAL	7-7-03	SOC
32	REVISION PER 7-6-03 SUPERVISORS' APPROVAL	7-7-03	SOC
33	REVISION PER 7-6-03 SUPERVISORS' APPROVAL	7-7-03	SOC
34	REVISION PER 7-6-03 SUPERVISORS' APPROVAL	7-7-03	SOC
35	REVISION PER 7-6-03 SUPERVISORS' APPROVAL	7-7-03	SOC
36	REVISION PER 7-6-03 SUPERVISORS' APPROVAL	7-7-03	SOC
37	REVISION PER 7-6-03 SUPERVISORS' APPROVAL	7-7-03	SOC
38	REVISION PER 7-6-03 SUPERVISORS' APPROVAL	7-7-03	SOC
39	REVISION PER 7-6-03 SUPERVISORS' APPROVAL	7-7-03	SOC
40	REVISION PER 7-6-03 SUPERVISORS' APPROVAL	7-7-03	SOC
41	REVISION PER 7-6-03 SUPERVISORS' APPROVAL	7-7-03	SOC
42	REVISION PER 7-6-03 SUPERVISORS' APPROVAL	7-7-03	SOC
43	REVISION PER 7-6-03 SUPERVISORS' APPROVAL	7-7-03	SOC
44	REVISION PER 7-6-03 SUPERVISORS' APPROVAL	7-7-03	SOC
45	REVISION PER 7-6-03 SUPERVISORS' APPROVAL	7-7-03	SOC
46	REVISION PER 7-6-03 SUPERVISORS' APPROVAL	7-7-03	SOC
47	REVISION PER 7-6-03 SUPERVISORS' APPROVAL	7-7-03	SOC
48	REVISION PER 7-6-03 SUPERVISORS' APPROVAL	7-7-03	SOC
49	REVISION PER 7-6-03 SUPERVISORS' APPROVAL	7-7-03	SOC
50	REVISION PER 7-6-03 SUPERVISORS' APPROVAL	7-7-03	SOC

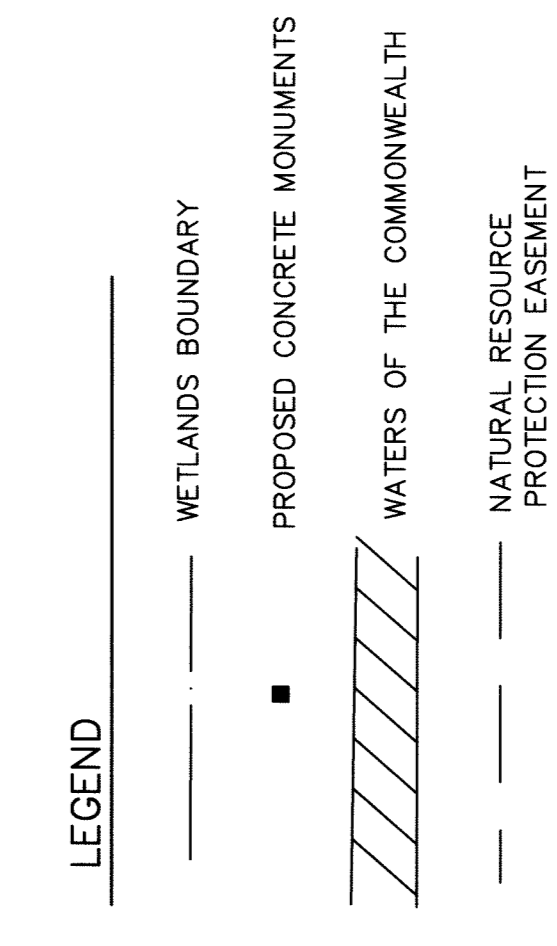

RECORDED IN THE OFFICE FOR THE RECORDING OF DEEDS, IN AND FOR THE COUNTY OF BUCKS, PENNSYLVANIA, ON THIS DAY OF \_\_\_\_\_, 2005. PAGE NO. \_\_\_\_\_ OF \_\_\_\_\_

APPROVED FOR APPROVAL BY THE SOLIBURY TOWNSHIP ENGINEER ON THE \_\_\_\_\_ DAY OF \_\_\_\_\_, 2005.

EXECUTIVE DIRECTOR: \_\_\_\_\_

NOTARY PUBLIC: \_\_\_\_\_

APPROVED BY RESOLUTION OF THE BOARD OF SUPERVISORS OF SOLIBURY TOWNSHIP, COUNTY OF BUCKS, COMMONWEALTH OF PENNSYLVANIA, AT A MEETING HELD ON THIS \_\_\_\_\_ DAY OF \_\_\_\_\_, 2005.

BY: \_\_\_\_\_

CLERK OF THE BOARD OF SUPERVISORS

APPROVED BY RESOLUTION OF THE BOARD OF SUPERVISORS OF SOLIBURY TOWNSHIP, COUNTY OF BUCKS, COMMONWEALTH OF PENNSYLVANIA, AT A MEETING HELD ON THIS \_\_\_\_\_ DAY OF \_\_\_\_\_, 2005.

BY: \_\_\_\_\_

CLERK OF THE BOARD OF SUPERVISORS

APPROVED BY RESOLUTION OF THE BOARD OF SUPERVISORS OF SOLIBURY TOWNSHIP, COUNTY OF BUCKS, COMMONWEALTH OF PENNSYLVANIA, AT A MEETING HELD ON THIS \_\_\_\_\_ DAY OF \_\_\_\_\_, 2005.

BY: \_\_\_\_\_

CLERK OF THE BOARD OF SUPERVISORS

**PEDDLER'S VIEW**

SOLIBURY TOWNSHIP, BUCKS COUNTY, PA.

CLIMORE & ASSOCIATES, INC.

CONSULTING ENGINEERS & LAND SURVEYORS

331 BUTLER AVENUE, NEW BRITAIN, PA. 18901

SCALE: 1" = 50'

SHEET NO. 5 OF 44

NO.	DESCRIPTION	DATE	BY
1	REVISION		
2	REVISION		
3	REVISION		
4	REVISION		
5	REVISION		
6	REVISION		
7	REVISION		
8	REVISION		
9	REVISION		
10	REVISION		
11	REVISION		
12	REVISION		
13	REVISION		
14	REVISION		
15	REVISION		
16	REVISION		
17	REVISION		
18	REVISION		
19	REVISION		
20	REVISION		
21	REVISION		
22	REVISION		
23	REVISION		
24	REVISION		
25	REVISION		
26	REVISION		
27	REVISION		
28	REVISION		
29	REVISION		
30	REVISION		
31	REVISION		
32	REVISION		
33	REVISION		
34	REVISION		
35	REVISION		
36	REVISION		
37	REVISION		
38	REVISION		
39	REVISION		
40	REVISION		
41	REVISION		
42	REVISION		
43	REVISION		
44	REVISION		
45	REVISION		
46	REVISION		
47	REVISION		
48	REVISION		
49	REVISION		
50	REVISION		